


# Tyncoed Villas

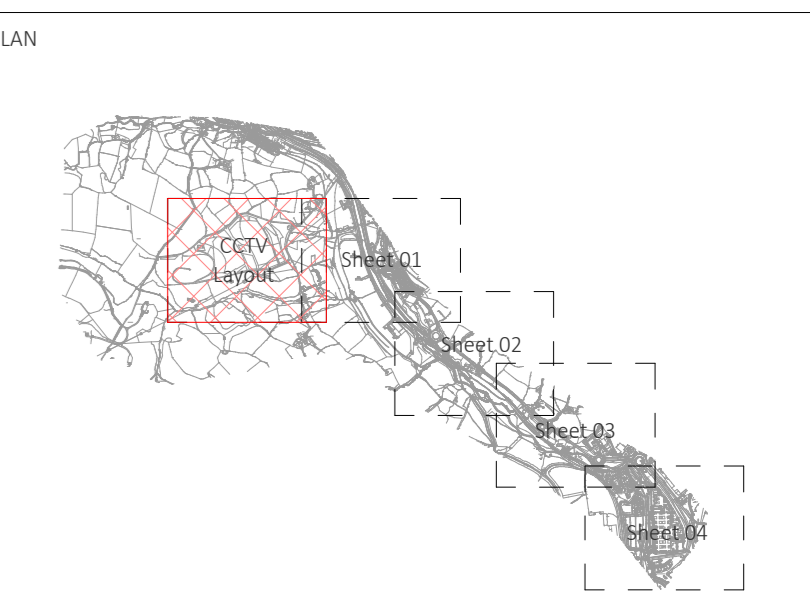

- NOTES
- All dimensions are to be checked on site before the commencement of works. Any discrepancies are to be reported to the Architect & Engineer for verification. Figure dimensions only are to be taken from this drawing.
  - This drawing is to be read in conjunction with all relevant engineers' and service engineers' drawings and specifications. This drawing is copyright.



One camera to be directed to keypath entry, one camera to be pointed down the path approaching the solar farm

Camera to be directed towards substation doors.

Cameras to be directed towards substation doors

REVISIONS

Rev.	Revision Description	Date	Drawn By	Checked	Approved By
P02	Updated following comments	06/07/23	AM		DW   AH
P03	Suitable for Review and Comment	18/06/23	AM		DW   AH

**Hydrock**  
 3rd Floor, Wharton Place  
 13 Wharton St  
 Cardiff  
 CF10 1GS  
 t: +44(0)2920 023665  
 e: cardiff@hydrock.com




CLIENT  
 Rhondda Cynon Taf  
 County Borough Council



PROJECT  
 Coed-Ely Solar Farm | Multi-Discipline  
 Consultant

TITLE  
 Electrical Services  
 Proposed Solar Farm CCTV Layout

HYDROCK PROJECT NO. C-27541	SCALE @ A0 1 : 1000
STATUS DESCRIPTION SUITABLE FOR REVIEW & COMMENT	STATUS S3
DRAWING NO. 27541-HYD-XX-XX-DR-Y-0016	REVISION P02

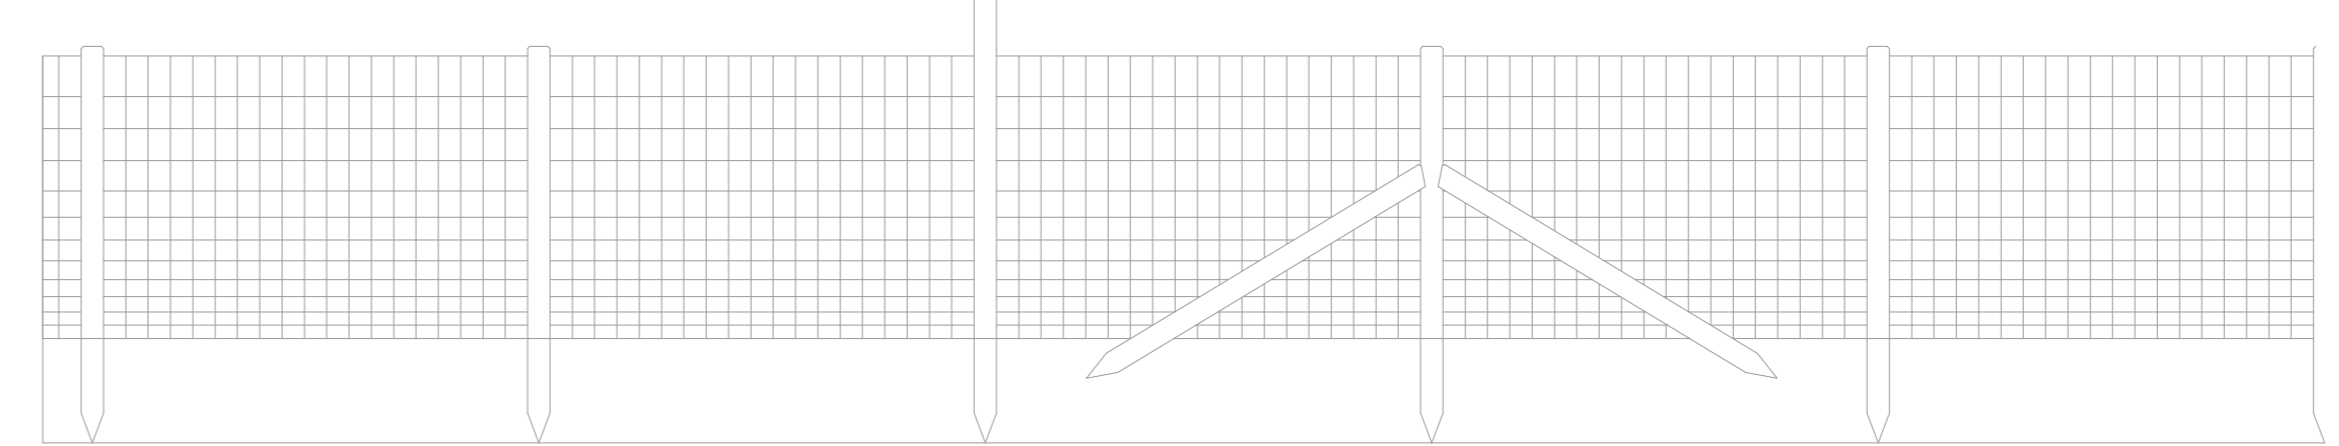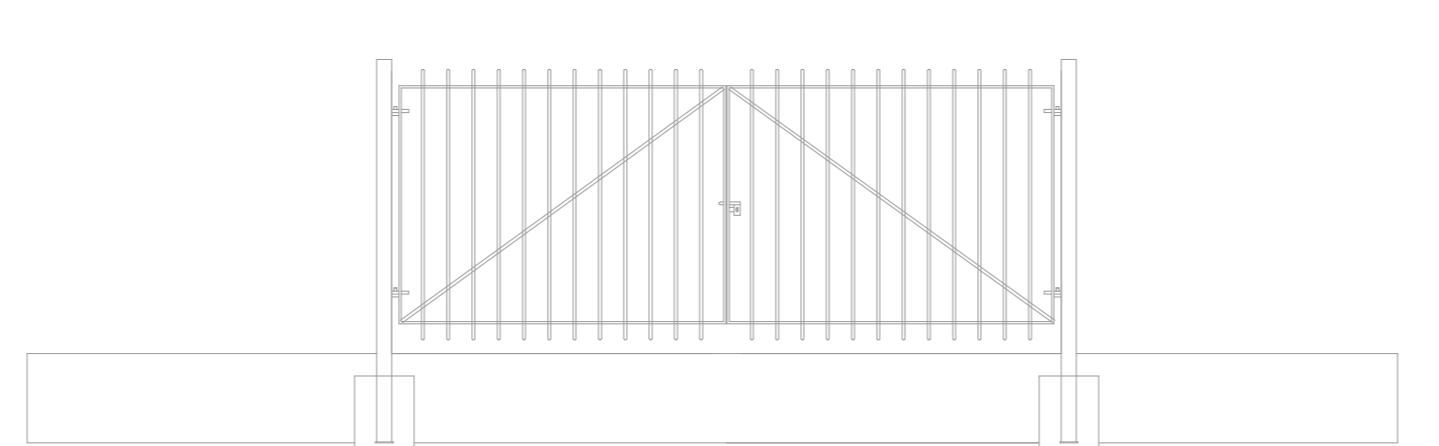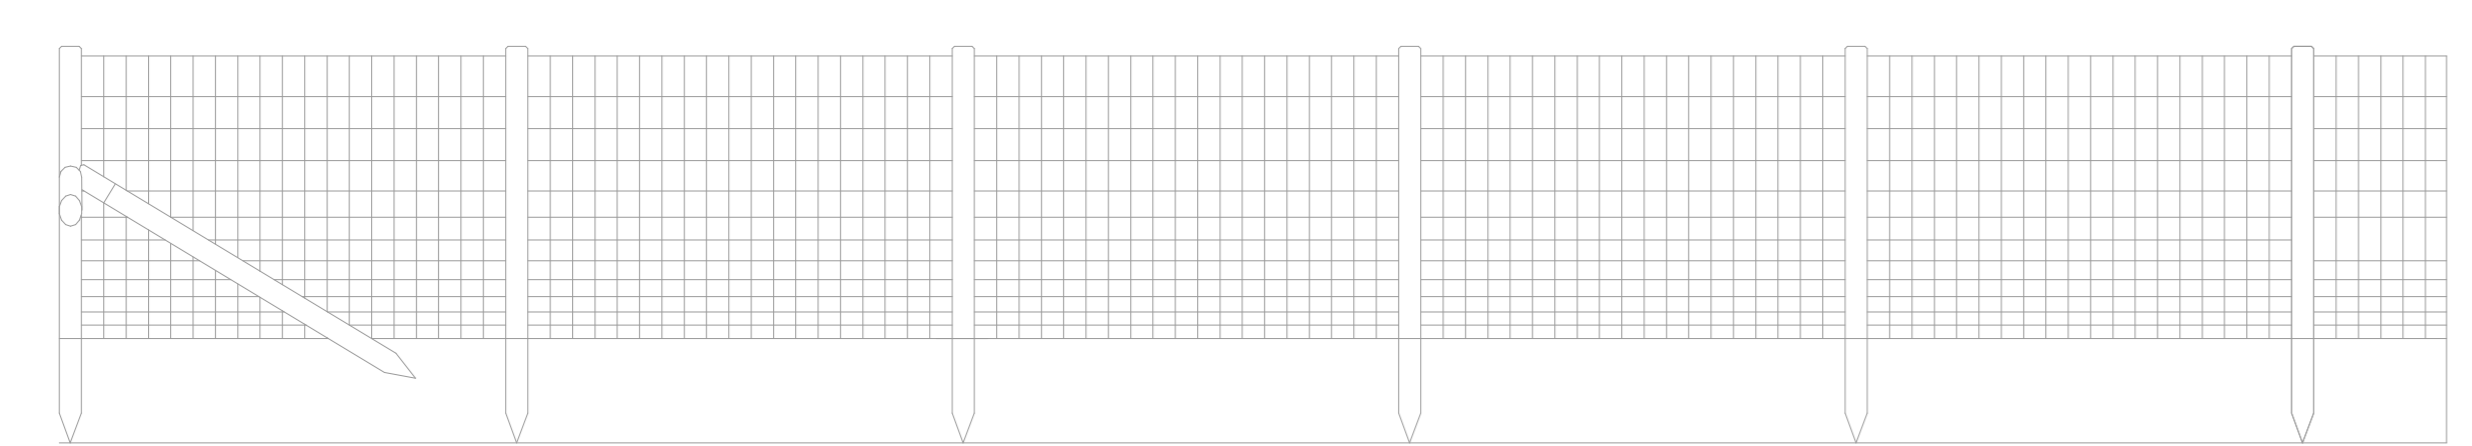

C:\Users\jacob.hobbes\Documents\27541\27541\_HYD\_XX-XX-XX-DR-Y-0016\_27541\_HYD\_XX-XX-XX-DR-Y-0016\_27541\_HYD\_XX-XX-XX-DR-Y-0016.dwg