

Roof Type 1

Roof lights

Roof lights

Gutter

Roof Type 3

Gutter

Roof Type 4


PV Panels arrangement by specialist

6.00'

6.00'

6.00'

UP

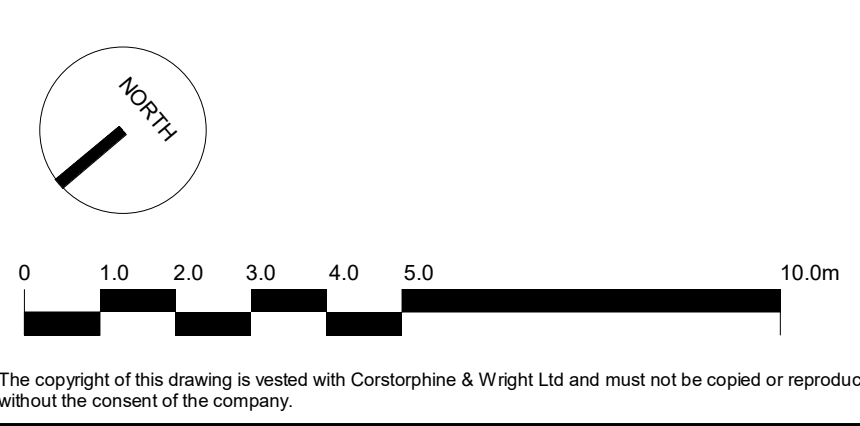


The copyright of this drawing is vested with Corstorphine & Wright Ltd and must not be copied or reproduced without the consent of the company.

P-02 Issue for pack PAC
P-01 First issue

18.08.2023	is	EHC
02.05.2023	SS	EHC
Rev.	Description	Date
	Draw.	Chk.

Roof Type 1 - Ballasted roof
Roof Type 3 - Built up roof
Roof Type 4 - Green roof

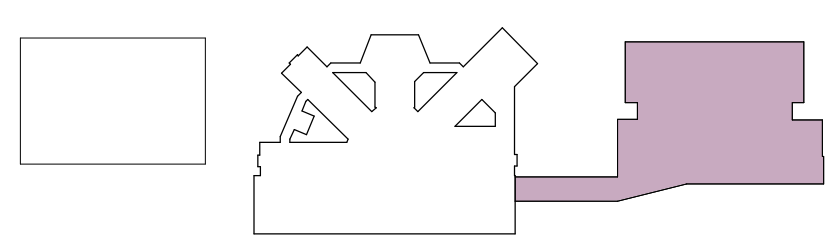

Client:
Willmott Dixon Construction Ltd.

Project:
Gwent Police Operational Facility

Drawing Title:
Training - Proposed Roof Plan

Drawing Status:
PLANNING

Corstorphine & Wright

Warwick Studio
Brook Hall, Brook Street, Warwick, CV34 4BL
01926 650 444
corstorphine-wright.com

Drawing No. GPOF-CWA-02-RF-DR-A-0312				Revision P-02
Drawn SS	Checked EHC	Paper Size A1	Scale 1 : 100	Date 17/04/2023